

1 2 3 4 5 6 7 8 9

A

B

C

D

E

F

A


B

C

D

E

F

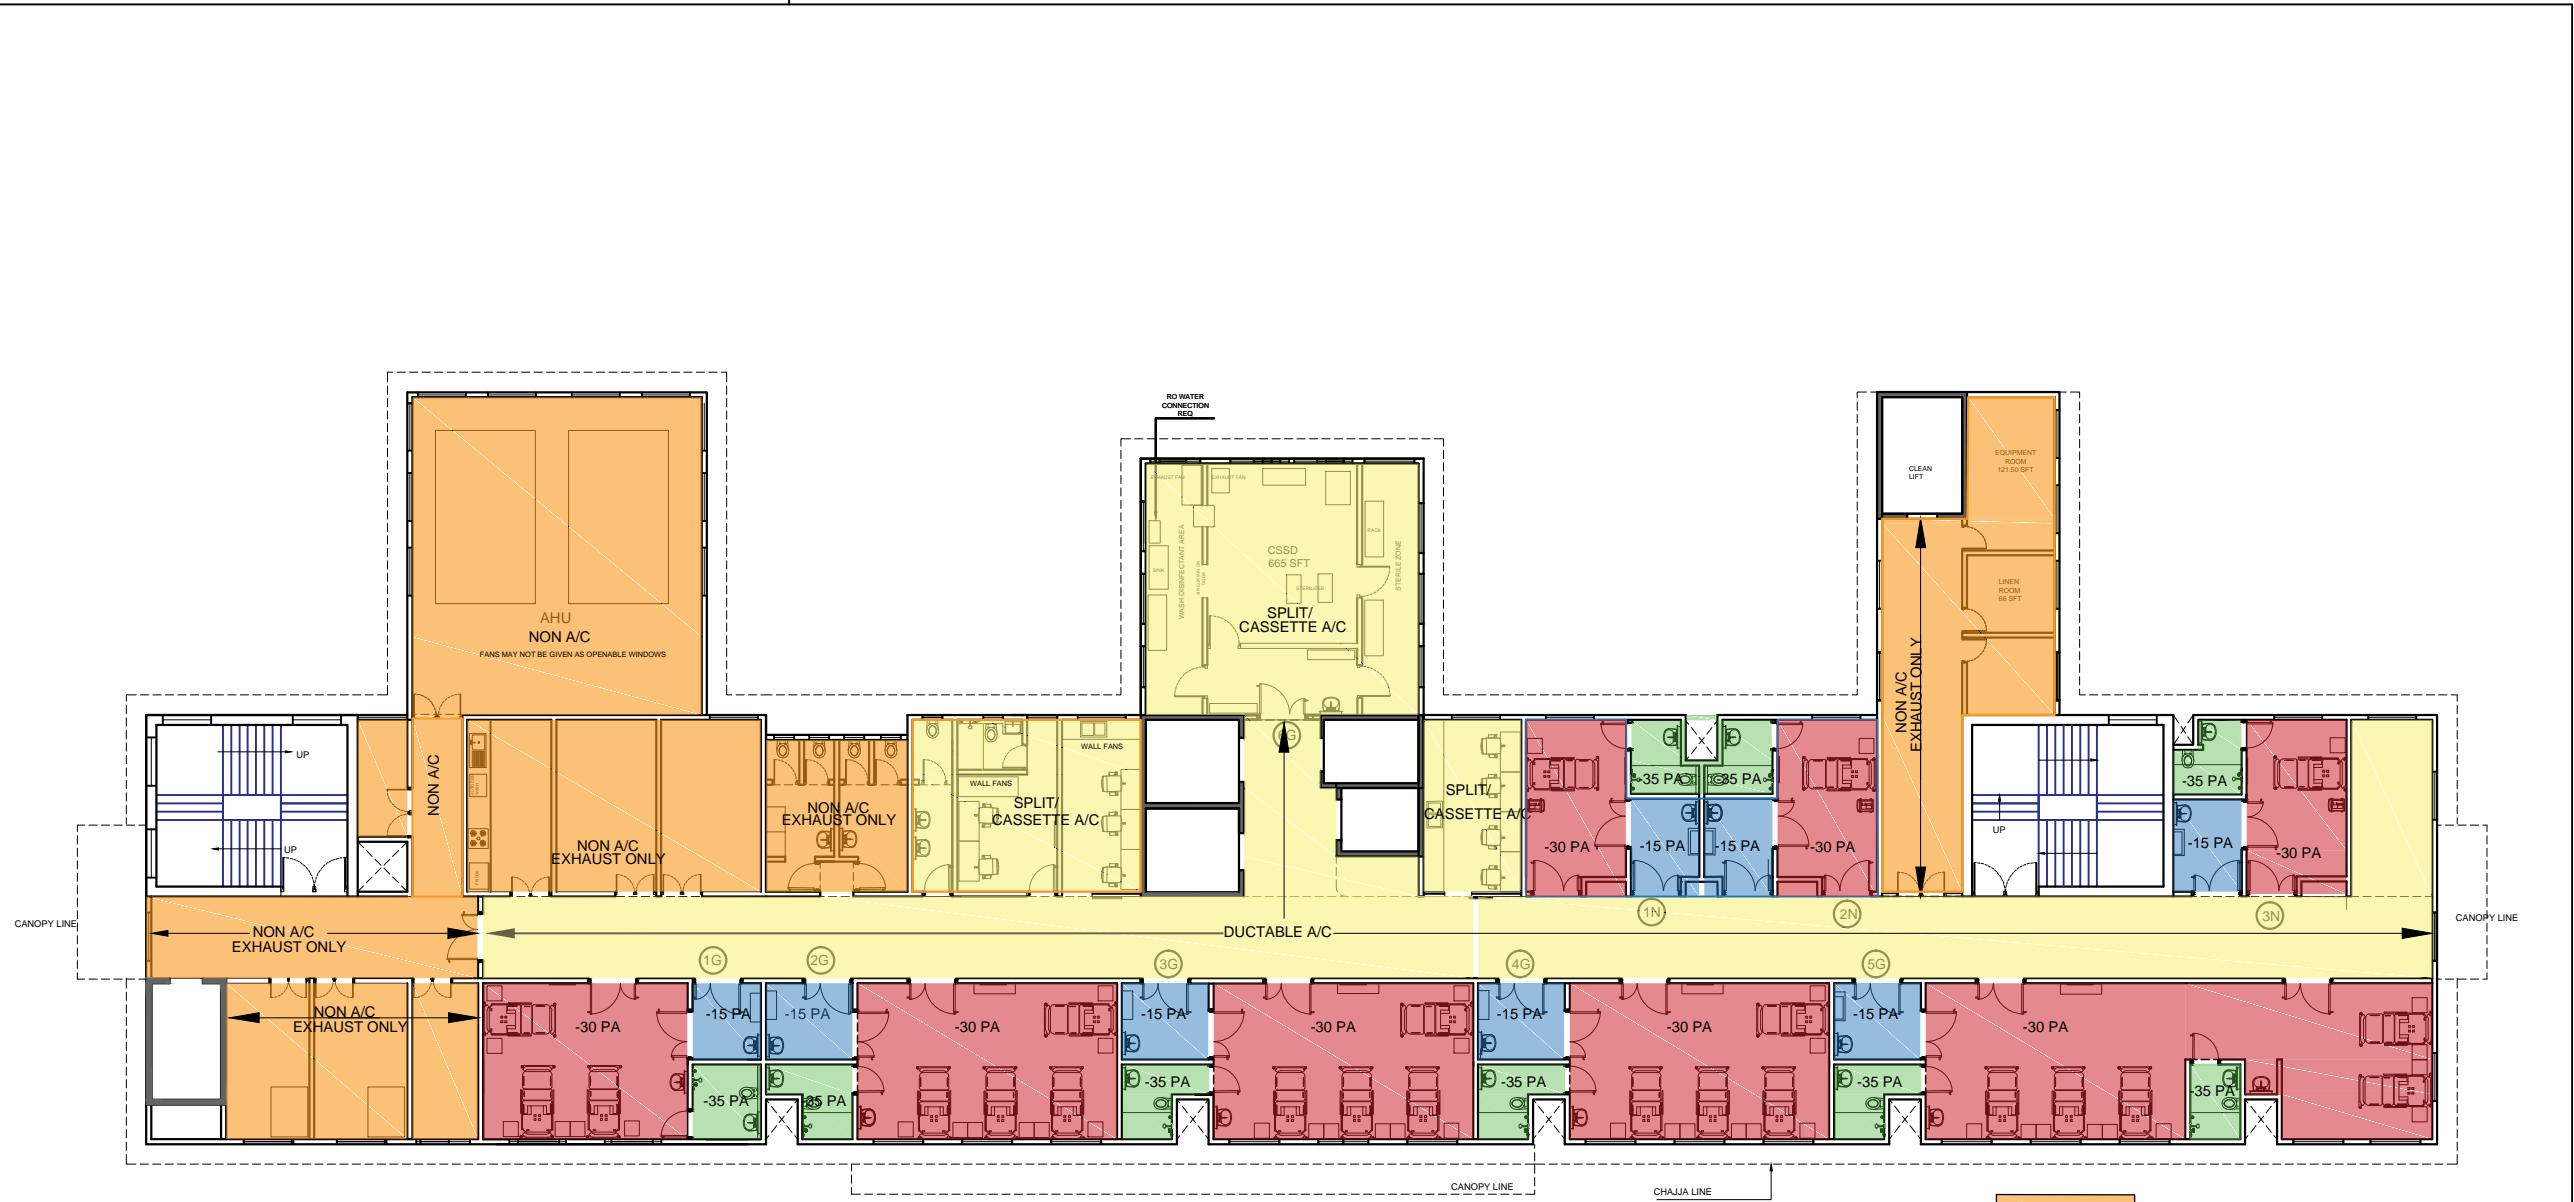

	NON A/C ONLY EXHAUST
	CLEAN AIR
	-15 PA
	-35 PA
	-30 PA

## FIRST FLOOR PLAN-PRESSURE LAYOUT KASTURBA HOSPITAL- WARD 15-PROPOSED LAYOUT

DRAWING TITLE:-		CLIENT:- MUNICIPAL CORPORATION OF GREATER MUMBAI		PROJECT:- PROPOSED CONSTRUCTION OF ISOLATION WARD FOR CORONA VIRUS AT KASTURBA HOSPITAL IN E WARD																																																															
DRAWN BY: SONAL		 <b>ARCHITECT/STRUCTURAL CONSULTANT:- FEMSTRUCT CONSULTING ENGINEERS LLP.</b> A1,304 KALPAK ESTATE,S.M.MARG, WADALA ( EAST),MUMBAI (400 037) E-MAIL:-femstruct@gmail.com MOB. :-+91 9766447704		RELEASED FOR:		<table border="1" style="width: 100%; border-collapse: collapse;"> <thead> <tr> <th>REV.</th> <th>DESCRIPTION</th> <th>DATE</th> <th>BY</th> <th>CHD.</th> <th>APRD.</th> </tr> </thead> <tbody> <tr><td> </td><td> </td><td> </td><td> </td><td> </td><td> </td></tr> <tr><td> </td><td> </td><td> </td><td> </td><td> </td><td> </td></tr> <tr><td> </td><td> </td><td> </td><td> </td><td> </td><td> </td></tr> <tr><td> </td><td> </td><td> </td><td> </td><td> </td><td> </td></tr> <tr><td> </td><td> </td><td> </td><td> </td><td> </td><td> </td></tr> <tr><td> </td><td> </td><td> </td><td> </td><td> </td><td> </td></tr> <tr><td> </td><td> </td><td> </td><td> </td><td> </td><td> </td></tr> <tr><td> </td><td> </td><td> </td><td> </td><td> </td><td> </td></tr> <tr><td> </td><td> </td><td> </td><td> </td><td> </td><td> </td></tr> </tbody> </table>		REV.	DESCRIPTION	DATE	BY	CHD.	APRD.																																																						
REV.	DESCRIPTION			DATE	BY			CHD.	APRD.																																																										
CHECKED BY:		<input type="checkbox"/> CONCEPT <input type="checkbox"/> SCHEMATIC <input type="checkbox"/> ADVANCE COPY <input type="checkbox"/> APPROVAL <input type="checkbox"/> CONSTRUCTION <input checked="" type="checkbox"/> TENDER																																																																	
APPROVED BY: G.P.R				REVISION SCHEDULE																																																															
SCALE: NTS																																																																			
DRG.NO:- FCEL/1252/19-20/KBN15/AR018		R0																																																																	

1 2 3 4 5 6 7 8 9

SIZE-A2